


动力	校工
电气	电讯
给排水	暖通
建筑	结构

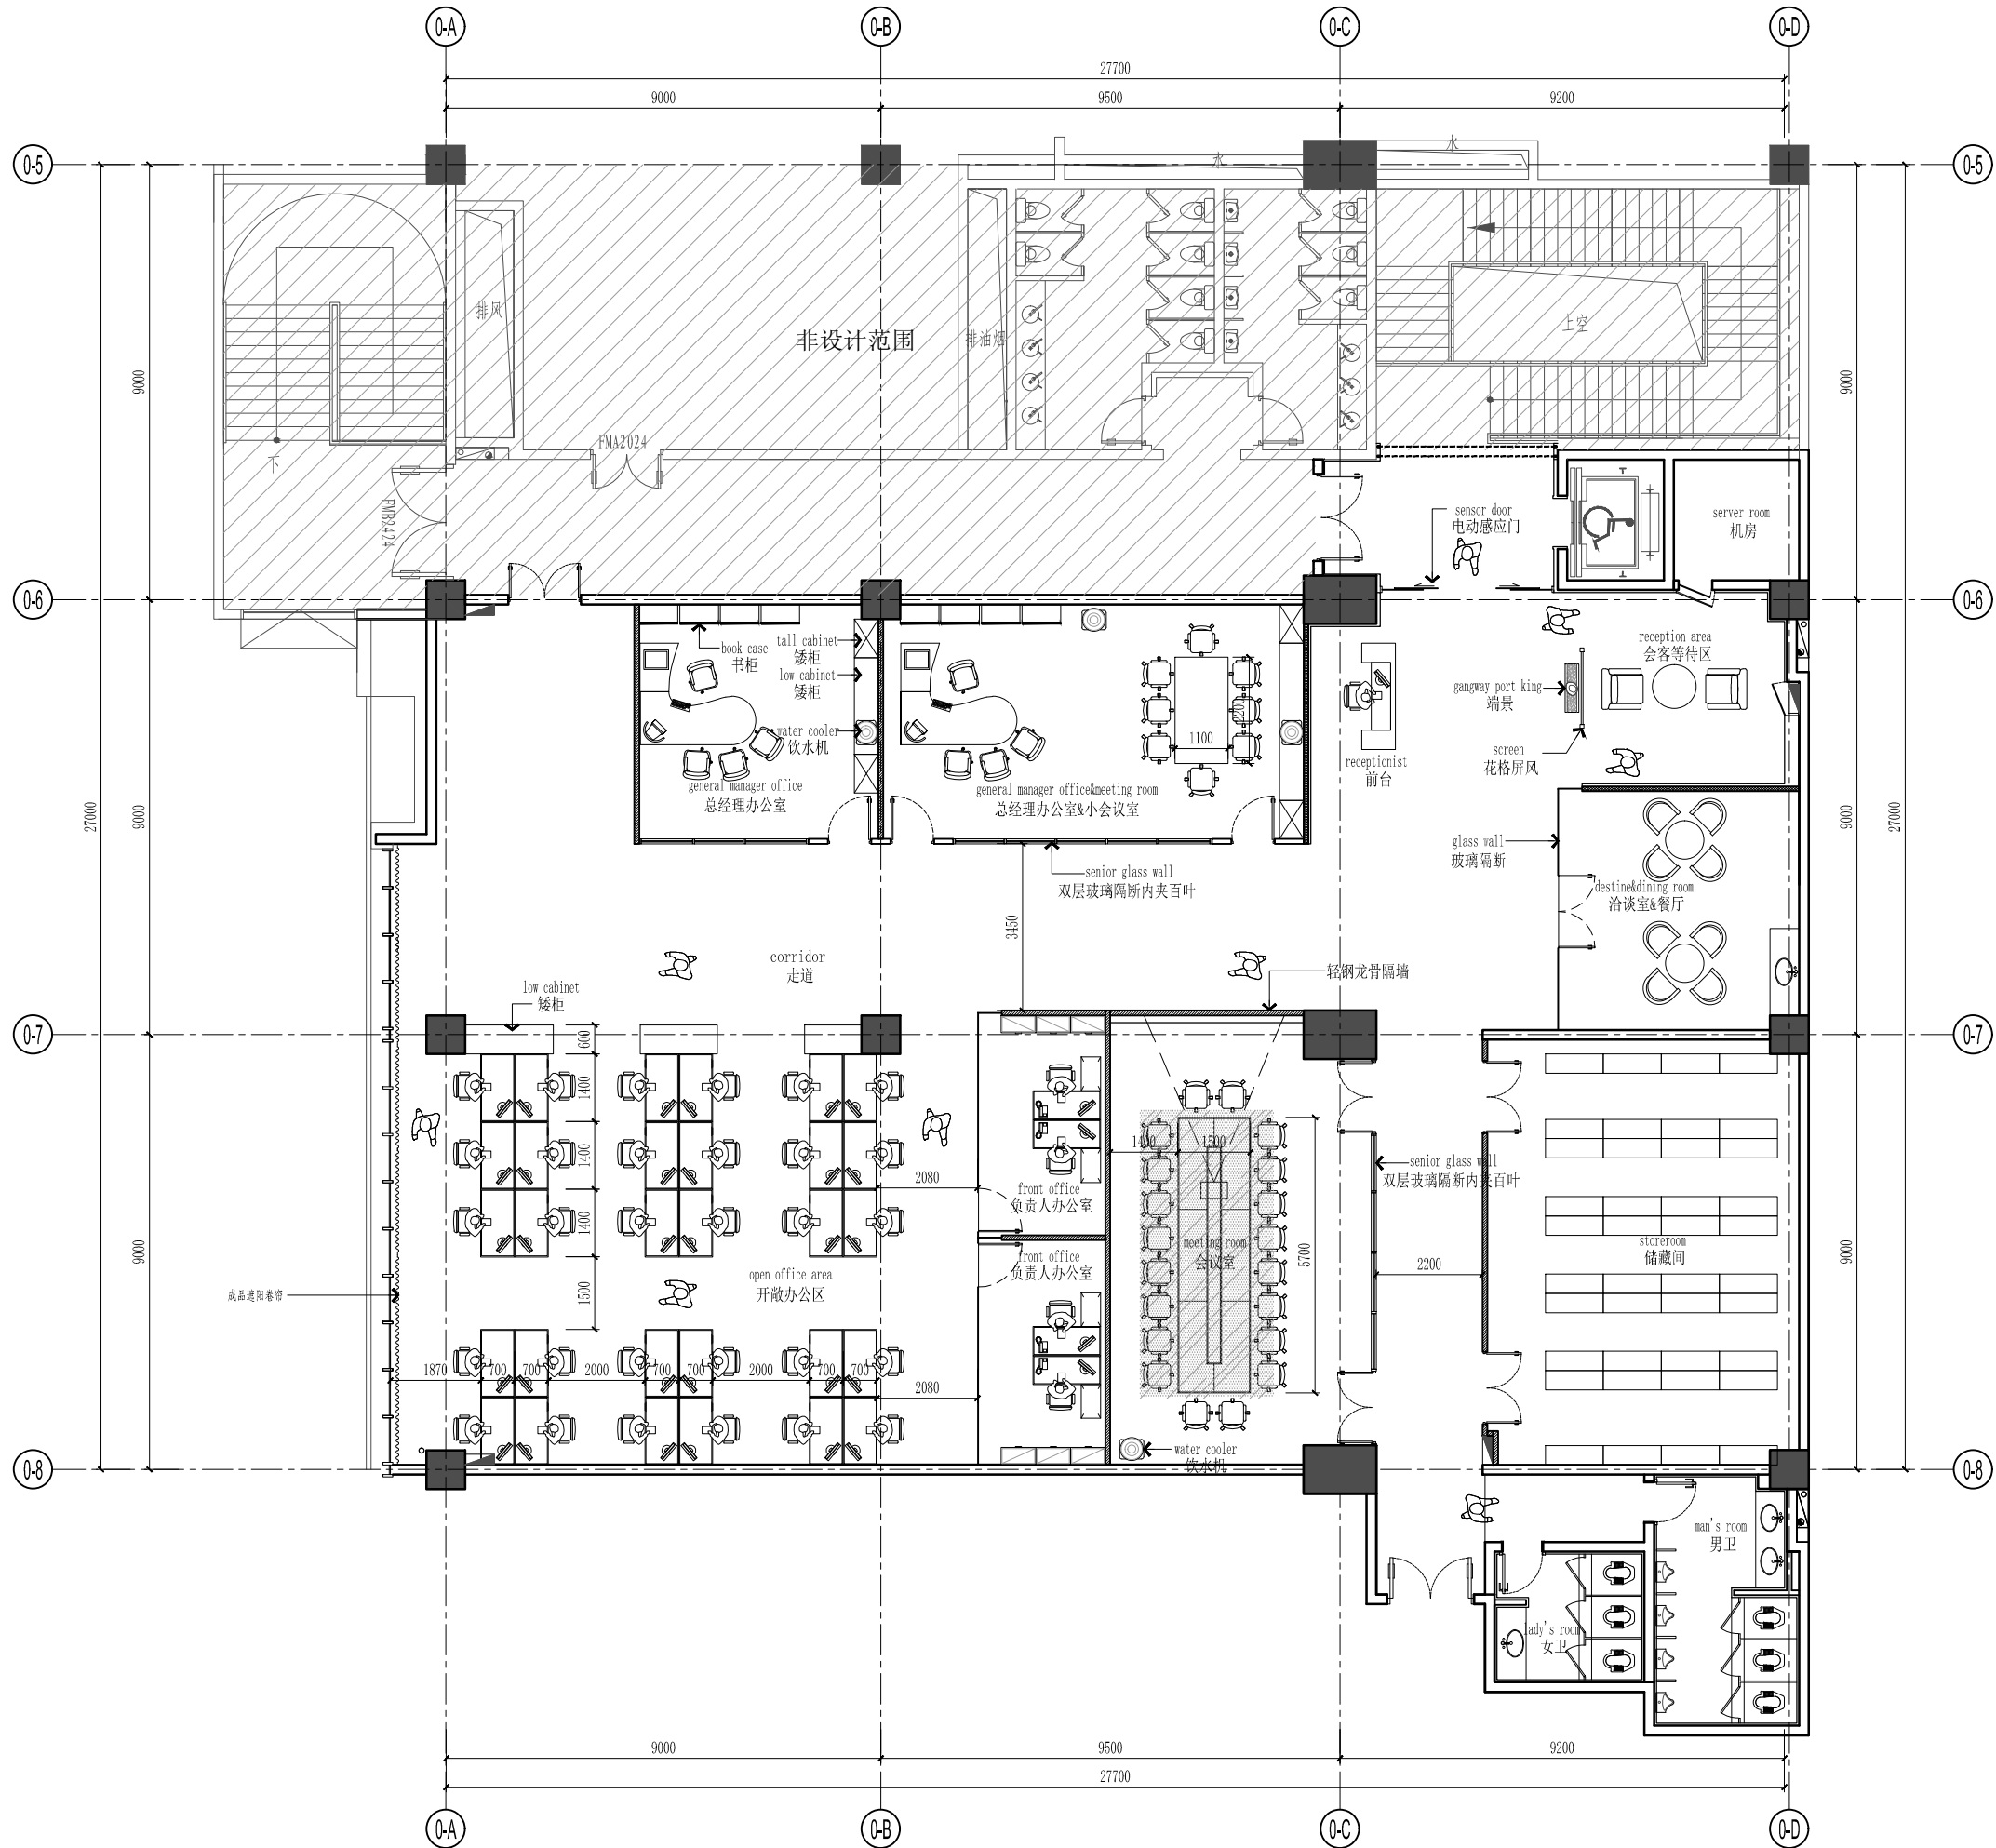

FF FIXTURE/FURNISHING PLAN

平面布置图

SCALE: 1/100

CLIENT 建设单位

建设单位

PROJECT TITLE 项目名称

项目名称英文翻译

DRAWING TITLE 图名

REVISIONS 版本

第一版 2016.12.25 第二版 -

第三版 - 第四版 -

第五版 - 第六版 -

APPROVED

审定

VERIFIED

审核

CHECKED

校对

DESIGNER

设计

DRAWN

制图

SCALE

比例

DATE

日期

2013.09.01

版权所有

施工时须以标注尺寸为准

施工单位须现场校核尺寸

如有不符须立即通知设计单位

This drawing is copyright

Copyright shall not be reproduced or distributed

Copyright shall not be reproduced or distributed

